


1 FLOOR PLAN
SCALE: 1/4" = 1'-0"
M-20

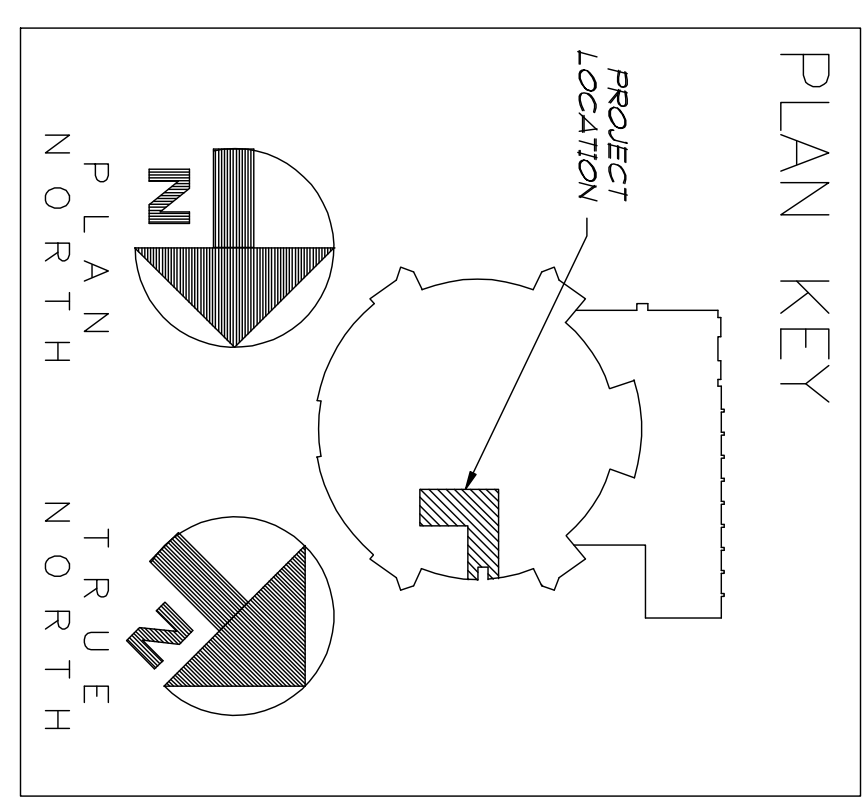

- GREASE DUCT NOTES:**
- DUCTWORK TO BE MADE OF 16 GAUGE BLACK STEEL.
 - ALL JOINTS, SEAMS AND PENETRATIONS TO BE A
 - DUCTWORK TO BE FLANGED, GASKETED AND BOLTED
 - TO INLET AND OUTLET OF EXHAUST FAN.
 - RATED DUCTWORK EQUIPPED WITH TWO LAYERS OF FIRE
 - CLEARANCES OF 3" FROM NON-COMBUSTIBLE AND 6" FROM COMBUSTIBLE MATERIAL WILL BE MAINTAINED.

1ST FLOOR KITCHEN HOOD DUCTWORK RENOVATION
WESTERN KENTUCKY UNIVERSITY, DIDDLE ARENA
BOWLING GREEN, KY

HVAC FLOOR PLAN

LYONS
JOB NUMBER
2999

SHEET NUMBER
M-2.0

CONSTRUCTION

LYONS COMPANY

LYONS COMPANY, INC.
Mechanical Contractors & Engineers

P.O. Box 393
308 Samson Street
Glasgow, Kentucky 42141

Phone: (270) 651-2733
Fax: (270) 651-6887

WWW.LYONSCOMPANY.COM

DATE	DESCRIPTION
07/27/04	GENERAL REVISIONS
08/27/04	GENERAL REVISIONS
07/17/04	FOR CONSTRUCTION

NOTES: This document, in whole or in part, is the property of LYONS Company and on which LYONS Company has proprietary rights. Neither receipt nor possession thereof confers or transfers any rights to reproduce the document or any part thereof, or to disclose any information contained therein to others, or to use it for any purpose without the written permission of LYONS Company.